


SHEET 2 OF 3

SHEET 1 OF 3

SHEET 3 OF 3

- NOTES:
- DO NOT SCALE. USE FIGURED DIMENSIONS ONLY.
 - THIS DRAWING IS TO BE READ IN CONJUNCTION WITH ALL OTHER RELEVANT ARCHITECTURAL AND ENGINEERING DRAWINGS.

This drawing should not be scaled. Dimensions to be verified on site.
Any discrepancies should be referred to the Engineer prior to work being put in hand.
This drawing is the property of Waterman Moylan Consulting Engineers Limited and is
issued on the condition that it is not copied, reproduced, retained or disclosed to any unauthorized person, either
wholly or in part without the consent in writing of
Waterman Moylan Consulting Engineers Limited
Block S East Point Business Park Dublin D03 H3F4 Ireland t+353 1 664 8900

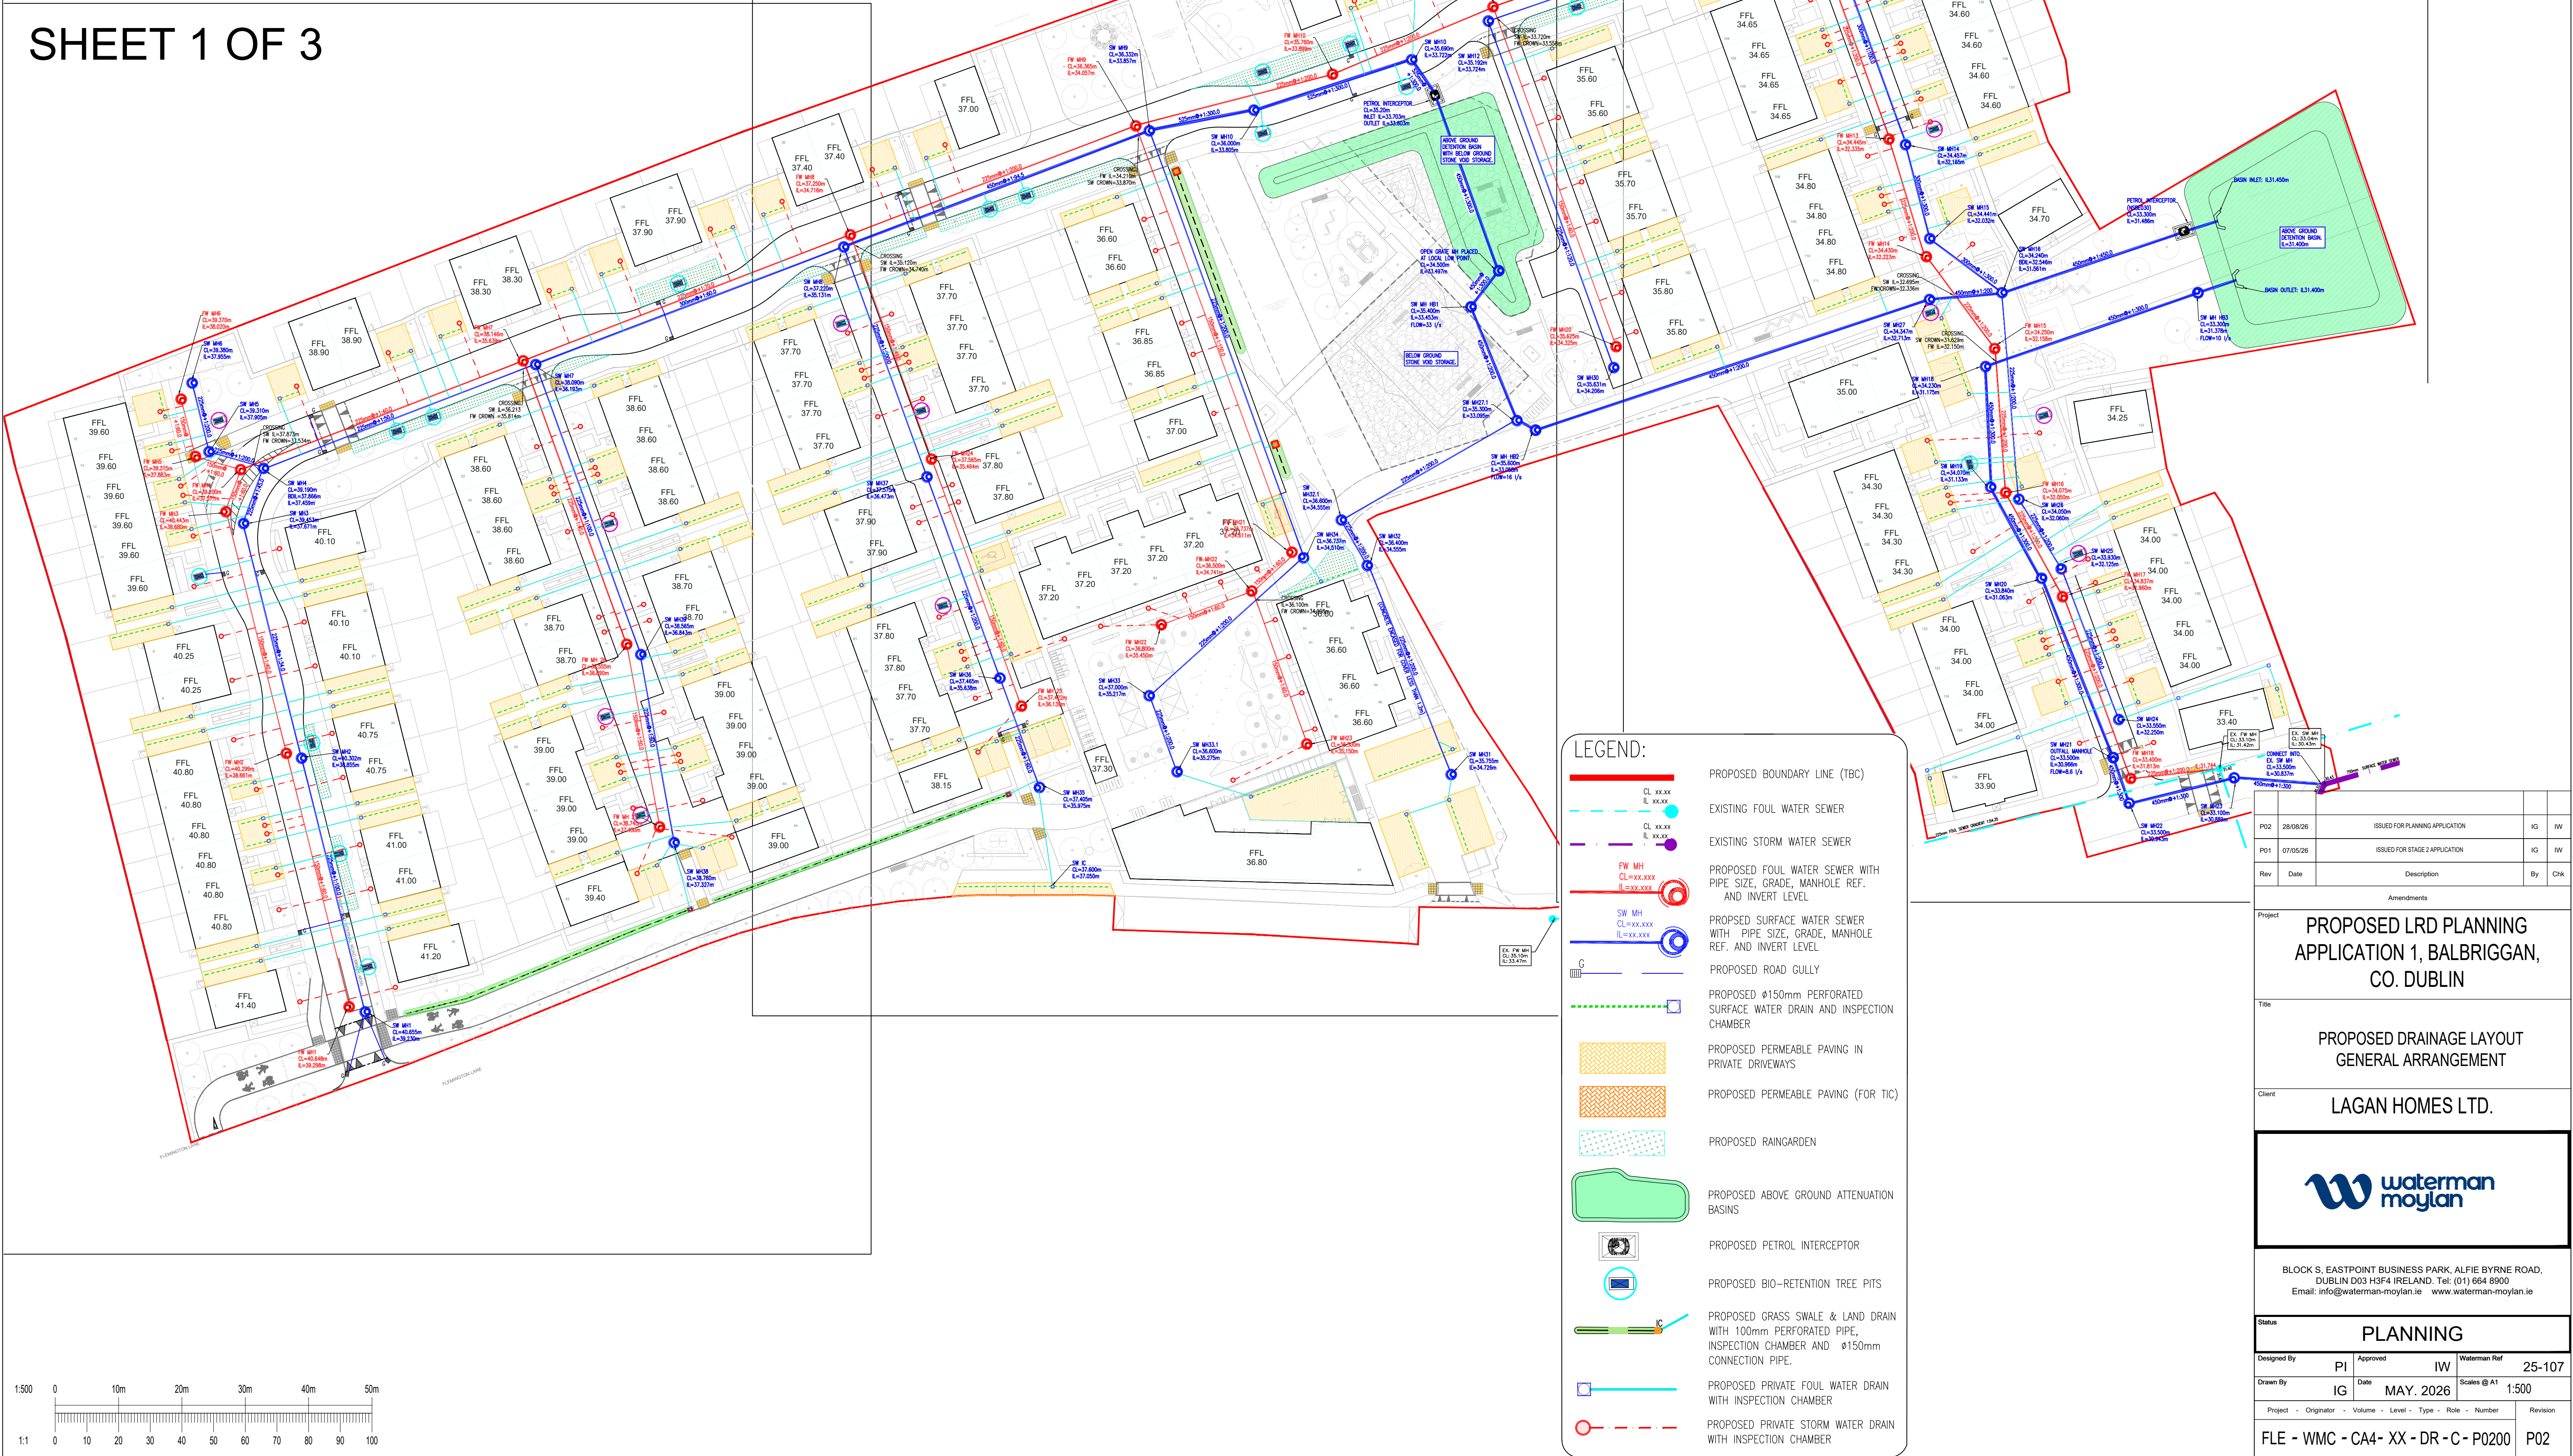

Rev	Date	Description	By	Chk
P02	28/08/25	ISSUED FOR PLANNING APPLICATION	IG	IV
P01	07/05/25	ISSUED FOR STAGE 2 APPLICATION	IG	IV

Project	PROPOSED LRD PLANNING APPLICATION 1, BALBRIGGAN, CO. DUBLIN
Title	PROPOSED DRAINAGE LAYOUT GENERAL ARRANGEMENT
Client	LAGAN HOMES LTD.

waterman moylan

BLOCK S, EASTPOINT BUSINESS PARK, ALFIE BYRNE ROAD,
DUBLIN D03 H3F4 IRELAND. Tel: (01) 664 8900
Email: info@waterman-moylan.ie www.waterman-moylan.ie

PLANNING	
Designed By	PI
Approved	IW
Date	MAY. 2026
Waterman Ref	25-107
Drawn By	IG
Project	FLE - WMC - CA4 - XX - DR - C - P0200
Revision	P02

