


LEGEND:



- CL xxx.xx
IL xxx.xx
- CL xxx.xx
IL xxx.xx
- FW MH
CL=xxx.xx
IL=xxx.xx
- SW MH
CL=xxx.xx
IL=xxx.xx
- PROPOSED ROAD GULLY
- PROPOSED Ø150mm PERFORATED SURFACE WATER DRAIN AND INSPECTION CHAMBER
- PROPOSED PERMEABLE PAVING IN PRIVATE DRIVEWAYS
- PROPOSED PERMEABLE PAVING (FOR TIC)
- PROPOSED RAINGARDEN
- PROPOSED ABOVE GROUND ATTENUATION BASINS
- PROPOSED PETROL INTERCEPTOR
- PROPOSED BIO-RETENTION TREE PITS
- PROPOSED GRASS SWALE & LAND DRAIN WITH 100mm PERFORATED PIPE, INSPECTION CHAMBER AND Ø150mm CONNECTION PIPE.
- PROPOSED PRIVATE FOUL WATER DRAIN WITH INSPECTION CHAMBER
- PROPOSED PRIVATE STORM WATER DRAIN WITH INSPECTION CHAMBER

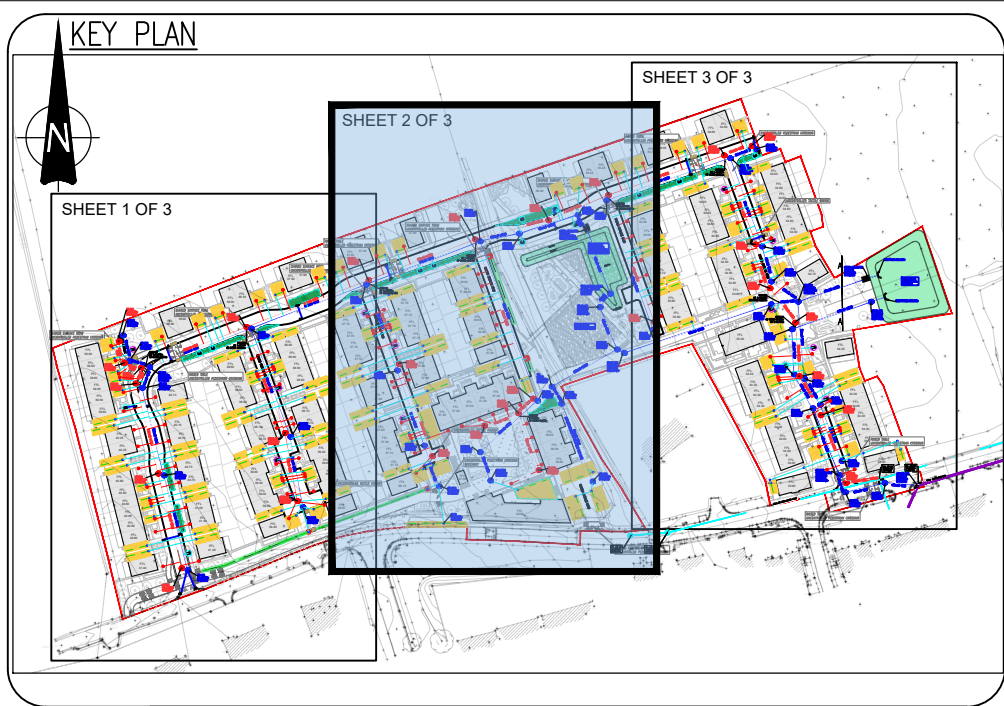

- NOTES:
- DO NOT SCALE. USE FIGURED DIMENSIONS ONLY.
 - THIS DRAWING IS TO BE READ IN CONJUNCTION WITH ALL OTHER RELEVANT ARCHITECTURAL AND ENGINEERING DRAWINGS.

This drawing should not be scaled. Dimensions to be verified on site. Any discrepancies should be referred to the Engineer prior to work being put in hand. This drawing is the property of Waterman Moylan Consulting Engineers Limited and is issued on the condition that it is not copied, reproduced, related or disclosed to any unauthorized person, either wholly or in part without the consent in writing of Waterman Moylan Consulting Engineers Limited. Block S, East Point Business Park, Dublin D03 H3F4 Ireland t+353 1 664 8900

Ordnance Survey Ireland Ordnance Survey Ireland Licence No. EN 0008023 © Ordnance Survey Ireland/Government of Ireland.

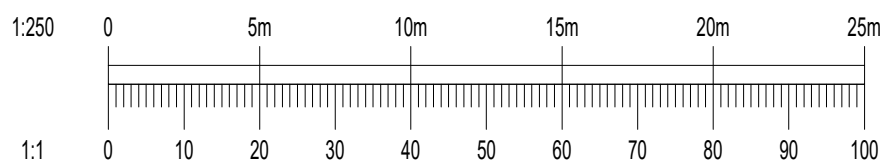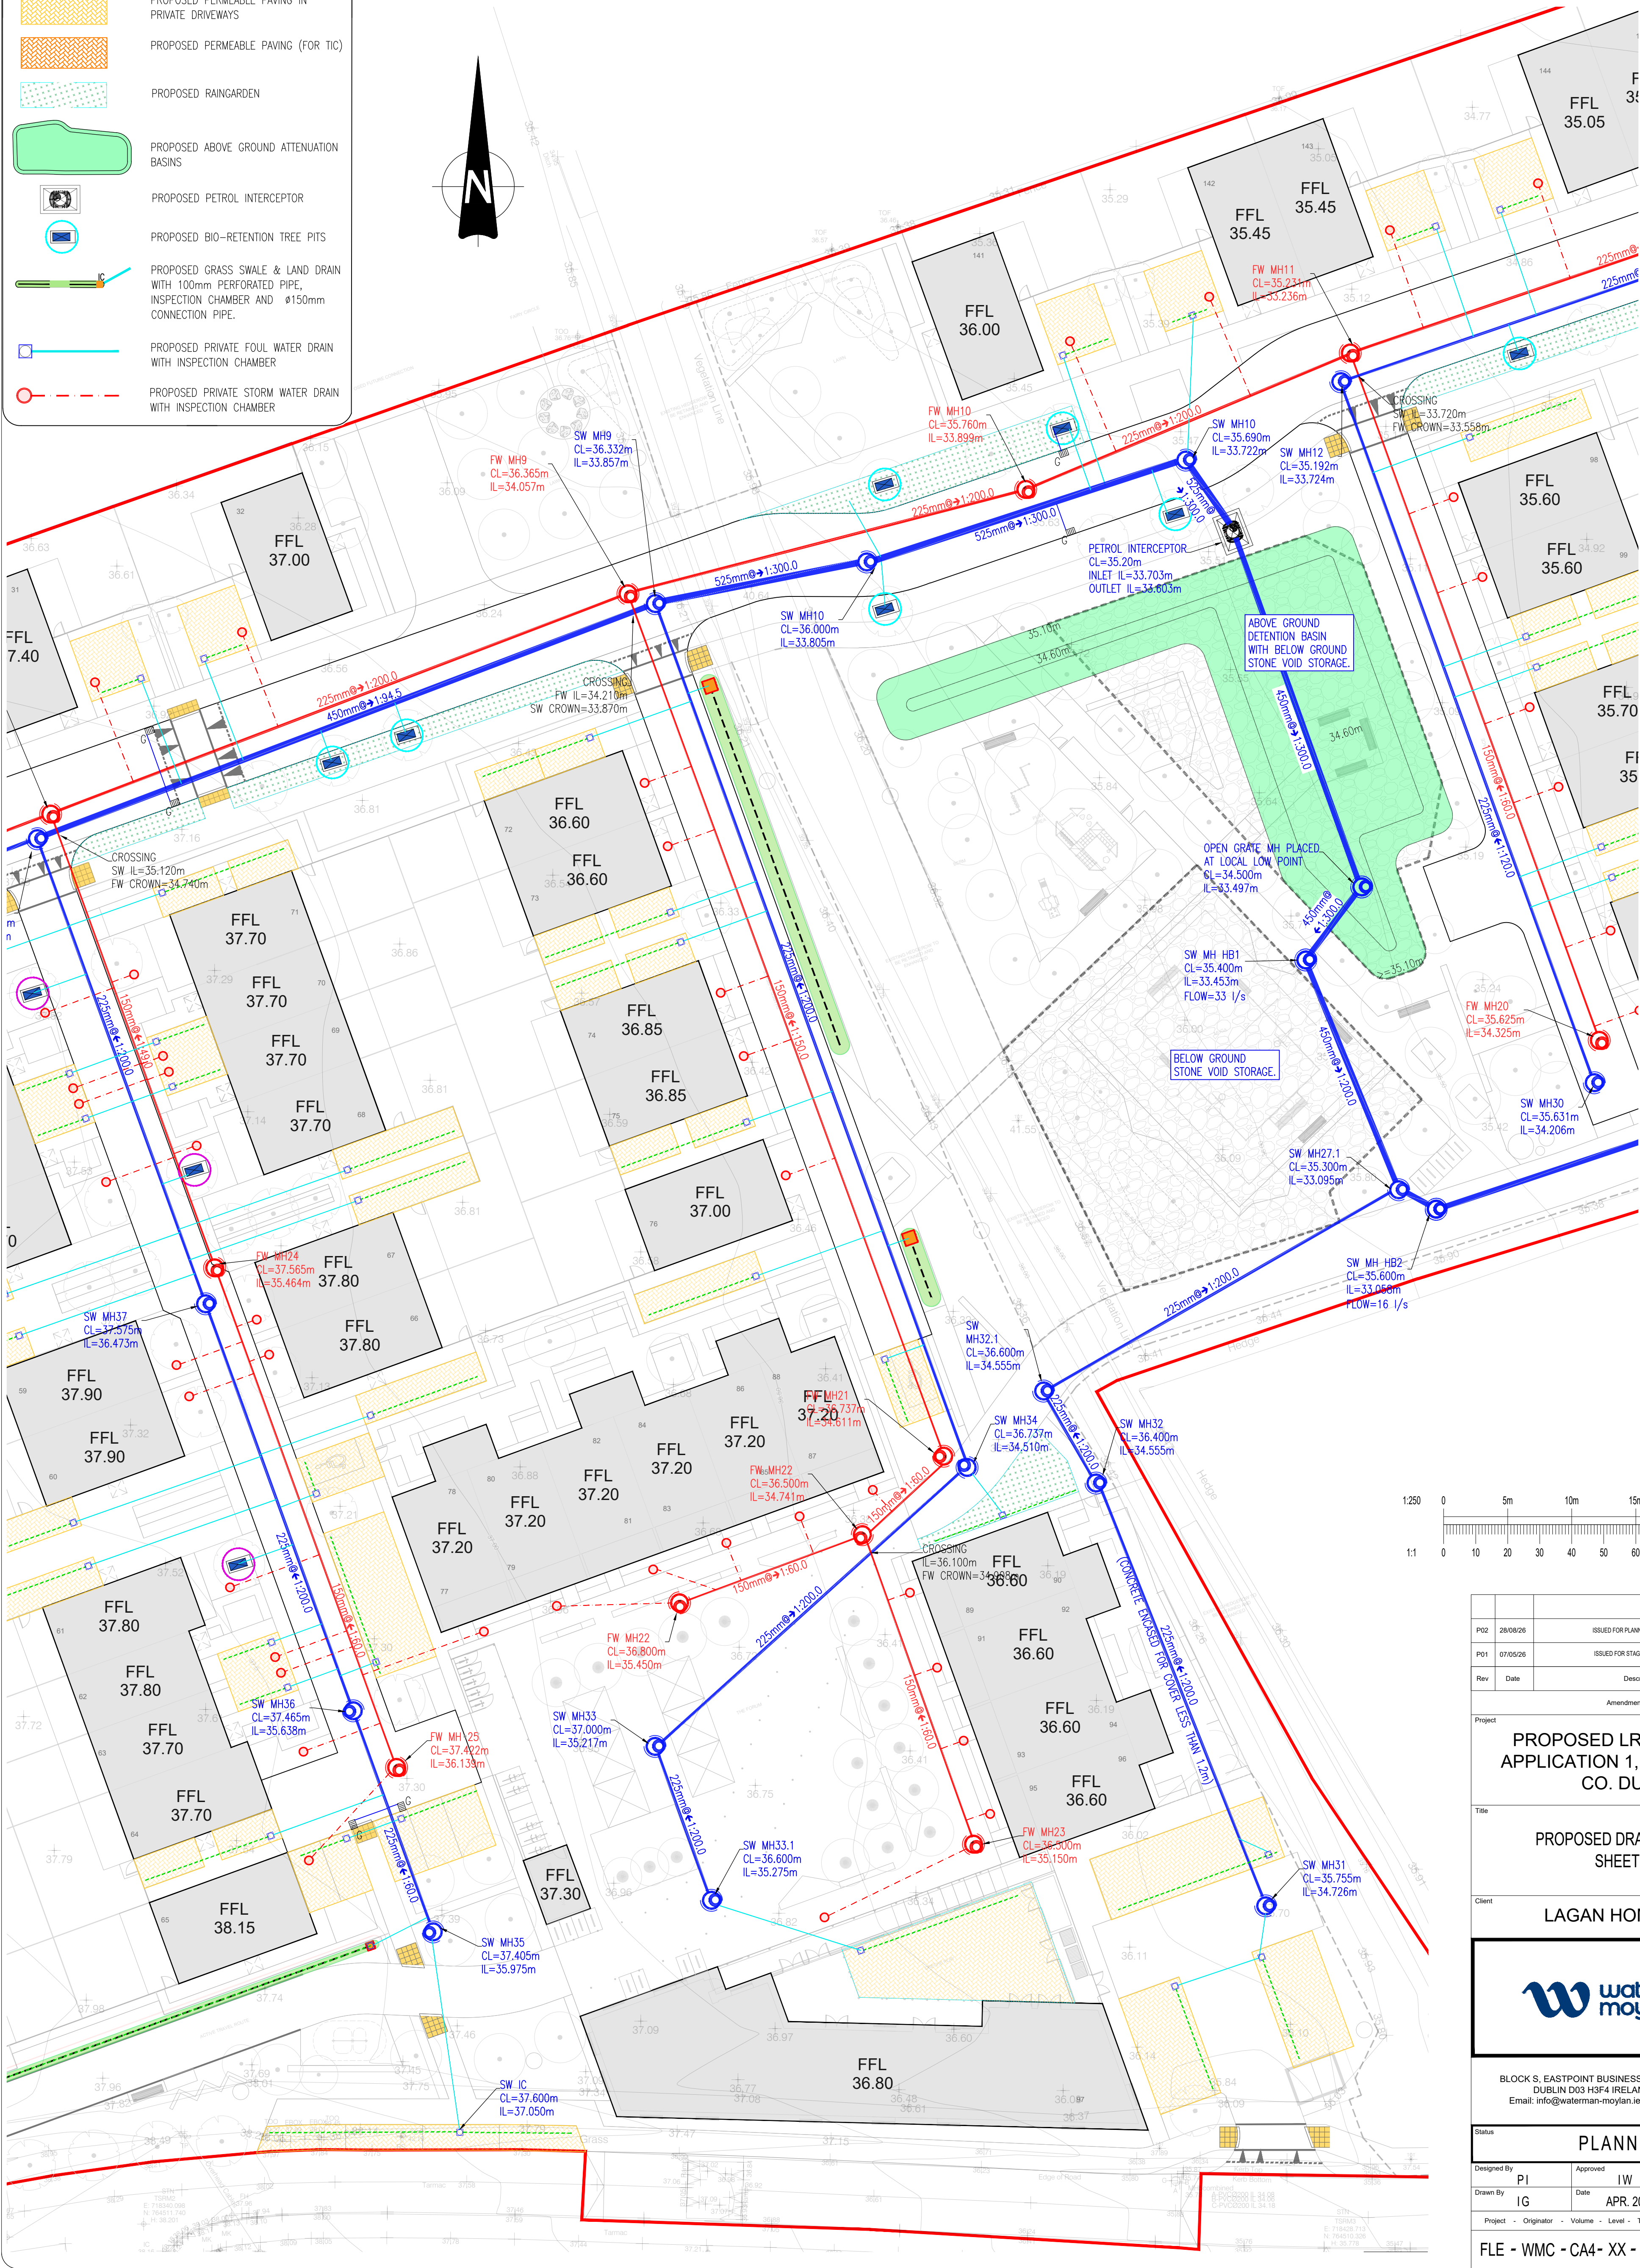

P02	28/08/26	ISSUED FOR PLANNING APPLICATION	IG	IW
P01	07/05/26	ISSUED FOR STAGE 2 APPLICATION	IG	IW
Rev	Date	Description	By	Chk

Project: **PROPOSED LRD PLANNING APPLICATION 1, BALBRIGGAN, CO. DUBLIN**

Title: **PROPOSED DRAINAGE LAYOUT SHEET 2 OF 3**

Client: **LAGAN HOMES LTD.**

waterman moylan

BLOCK S, EASTPOINT BUSINESS PARK, ALFIE BYRNE ROAD, DUBLIN D03 H3F4 IRELAND. Tel: (01) 664 8900 Email: info@waterman-moylan.ie www.waterman-moylan.ie

Status: **PLANNING**

Designed By	PI	Approved	IW	Waterman Ref	25-107		
Drawn By	IG	Date	APR 2026	Scales @ A1	1:250		
Project	Originator	Volume	Level	Type	Role	Number	Revision
FLE - WMC - CA4 - XX - DR - C - P0202	P02						